


<b>N1 (W28) Wind Category</b>	<b>Bushfire Attack Level</b> <b>"LOW"</b> Refer to BAL Certificate Ref. BPD-PA-26512 - Dated: 23/04/2018
-------------------------------	---

<b>N1 (W28) Wind Category</b>	<b>Bushfire Attack Level</b> <b>"LOW"</b> Refer to BAL Certificate Ref. BPD-PA-26512 - Dated: 23/04/2018
-------------------------------	---

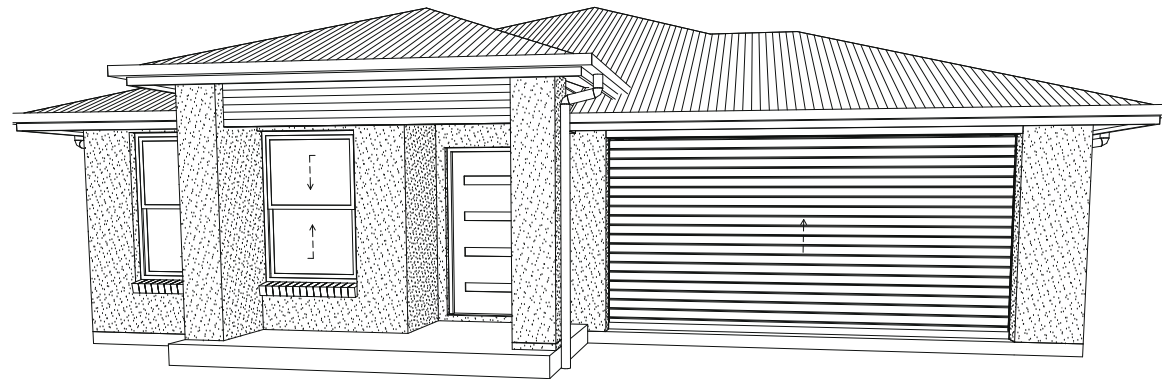

**NOTES:**  
IMAGES ARE DIAGRAMATIC ONLY  
REFER TO ELEVATIONS FOR DETAILS

16	Basix 2
15	Basix 1
14	Roof Tiedown Details
13	Tiedown Details
12	Landscape Plan
11	Waste Plan
10	Slab Plan
9	Driveway & Drainage
8	Section & Details
7	Electrical Plan
6	Internal Elevations
5	Elevations
4	Elevations
3	Floor Plans
2	Site Plan
1	Cover Sheet
<b>SHEET</b>	<b>DESCRIPTION</b>

**CONSTRUCTION SET / CDC/109688 Dated: 07/09/2018**



Address: P.O. BOX 600  
PARADISE POINT, 4216  
[www.gdevelopments.com.au](http://www.gdevelopments.com.au)

ACN: 116332220  
ABN: 77116332220  
QBSA: 1086689

### "Building a Shared Vision"

**(C)** All Content Copyrighted:-  
This design and/or print is the property of G Developments P/L and is protected by the Commonwealth Copyright Act 1968. It must not be used or reproduced in whole or in part without written permission. Any attempt to copy, use or reproduce the same, in whole or in part, will result in legal proceedings.

**GENERAL NOTES:**  
Drawings are to be read in conjunction with the relevant client-builder contract. Contractor is to take precedence over drawings including but not limited to: finishes, inclusions, upgrades, exclusions, additional costs and works by the owner/builder. Incorrect inclusions or omissions or typographical errors are not to be used in the interpretation of any information in these drawings. Nor can they be used to claim any additional or alternate items or services as a result of such errors. The incorrect or omitted details shall be subject to the client's correction by the building company and documentation revised.

**DIMENSIONS TO BE READ IN PREFERENCE TO SCALING**

Rev	Date	Description "I & O not used"
C	11/09/2018	Construction Set, Incl PCV1
B	17/07/2018	Complete Pre-Construction Set, Incl. Basic Certificate
A	04/07/2018	Complete Pre-Construction Set

Client Approval: \_\_\_\_\_ Date: \_\_\_\_\_

**"Once this set of plans has been signed off, G Developments will not accept any more changes"**


Product:  
**Salerno**  
Facade Plantation  
Garage to Right

Cover Sheet			
Plot Date: 14/09/2018	Drawn: MAD		Rev:
Scale:	Checked: WM	Checked Date: 11/09/2018	<b>C</b>
Sheet: <b>1</b>	Job No: <b>N405410</b>		

**Provide Ducted Air Conditioning**  
Final location & sizes of units and outlets to be determined by supplier / installer.  
Roof truss strengthening and void in trusses required for A/C system in roof space.






Roof Info		Roof Area Diverted	
		Area m2	117.
Roof Area m2	304.8	Unconditioned Area	
Roof Pitch	22.50°	Area m2	18.

 <p>Address: P.O. BOX 600 PARADISE POINT, 4216 www.gdevelopments.com.au</p> <p>QCN: 116332220 ABN: 77114332220 GAS: 106689</p> <p>"Building a Shared Vision"</p>	<p><b>All Content Copyrighted:</b> This set of plans and drawings are the property of G Developments Pty Ltd. and are protected by the Commonwealth Copyright Act 1968. It must not be used or reproduced in whole or in part without written permission from G Developments Pty Ltd. Any unauthorised use or reproduction in whole or in part, without written permission, is a breach of copyright and may result in legal proceedings.</p> <p><b>GENERAL NOTES:</b> Drawings are to be read in conjunction with the relevant client/builder contract. Contract is to take precedence over drawings including but not limited to: fixtures, inclusions, exclusions, additional costs and notes by the owner/builder. Incomplete inclusions or omissions or typographical errors are not to be used in the interpretation of any information or these drawings are to be read in conjunction with the relevant contract. Any errors or omissions are the result of such errors. The inaccuracy or omitted details shall be subject to subsequent correction by the building company and documentation as required.</p> <p><b>DIMENSIONS TO BE READ IN PREFERENCE TO SCALING.</b></p>	<table border="1"> <thead> <tr> <th>Rev</th> <th>Date</th> <th>Description "I &amp; O not used"</th> </tr> </thead> <tbody> <tr> <td>C</td> <td>11/09/2018</td> <td>Construction Set, Incl PCV1</td> </tr> <tr> <td>B</td> <td>17/07/2018</td> <td>Complete Pre-Construction Set, Incl Basis Certificate</td> </tr> <tr> <td>A</td> <td>04/07/2018</td> <td>Complete Pre-Construction Set</td> </tr> </tbody> </table>	Rev	Date	Description "I & O not used"	C	11/09/2018	Construction Set, Incl PCV1	B	17/07/2018	Complete Pre-Construction Set, Incl Basis Certificate	A	04/07/2018	Complete Pre-Construction Set	<p>Product: <b>Salerno</b></p> <p>Facade Plantation Garage to Right</p>	<table border="1"> <thead> <tr> <th colspan="3">Floor Plans</th> </tr> </thead> <tbody> <tr> <td>Plot Date: 14/09/2018</td> <td>Drawn: MAD</td> <td>Rev: A</td> </tr> <tr> <td>Scale: 1:100</td> <td>Checked: WM</td> <td>Checked Date: 11/09/2018</td> </tr> <tr> <td>Sheet: <b>3</b></td> <td>Job No: <b>N405410</b></td> <td>MAD Ref: MAD-2018074</td> </tr> </tbody> </table>	Floor Plans			Plot Date: 14/09/2018	Drawn: MAD	Rev: A	Scale: 1:100	Checked: WM	Checked Date: 11/09/2018	Sheet: <b>3</b>	Job No: <b>N405410</b>	MAD Ref: MAD-2018074
	Rev	Date	Description "I & O not used"																									
C	11/09/2018	Construction Set, Incl PCV1																										
B	17/07/2018	Complete Pre-Construction Set, Incl Basis Certificate																										
A	04/07/2018	Complete Pre-Construction Set																										
Floor Plans																												
Plot Date: 14/09/2018	Drawn: MAD	Rev: A																										
Scale: 1:100	Checked: WM	Checked Date: 11/09/2018																										
Sheet: <b>3</b>	Job No: <b>N405410</b>	MAD Ref: MAD-2018074																										
	<p>Client Approval: _____ Date: _____</p> <p><b>"Once this set of plans has been signed off, G Developments will not accept any more changes"</b></p>																											

N1 (W28) Wind Category

Bushfire Attack Level  
"LOW"  
Refer to BAL Certificate  
Ref. BPD-PA-26512 - Dated: 23/04/2018

Note: 450mm Eave U.N.O.  
Note: Fly screens to all windows & sliding glass door  
Entry door note:  
Entry door style shown is indicative only.  
Refer to the contract for further details  
Provide full ht. Masonry articulation at 5.0m max. Crs as per engineers report

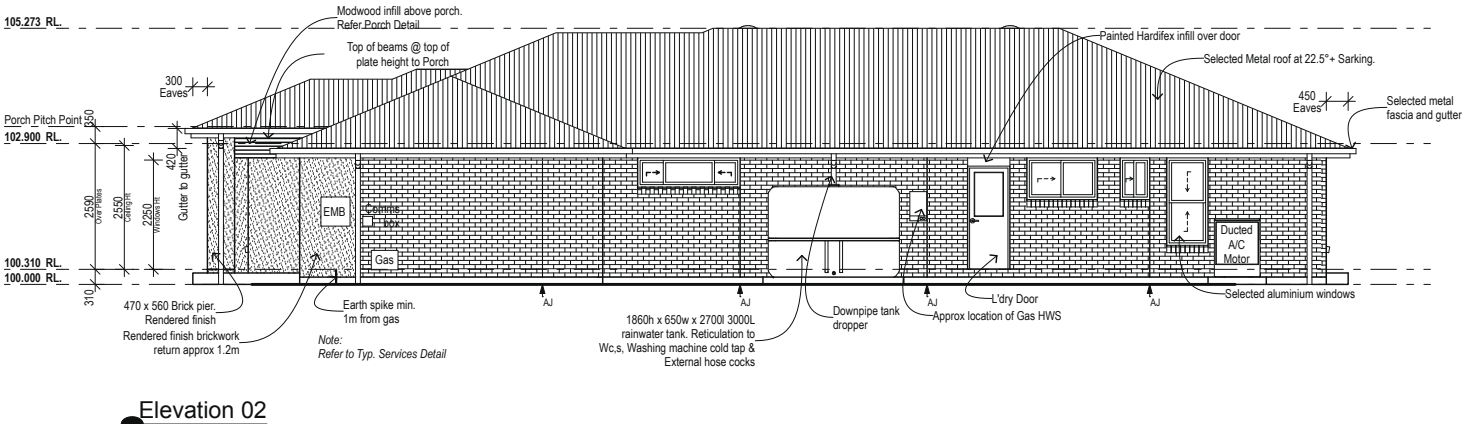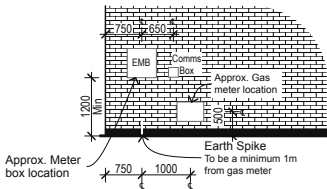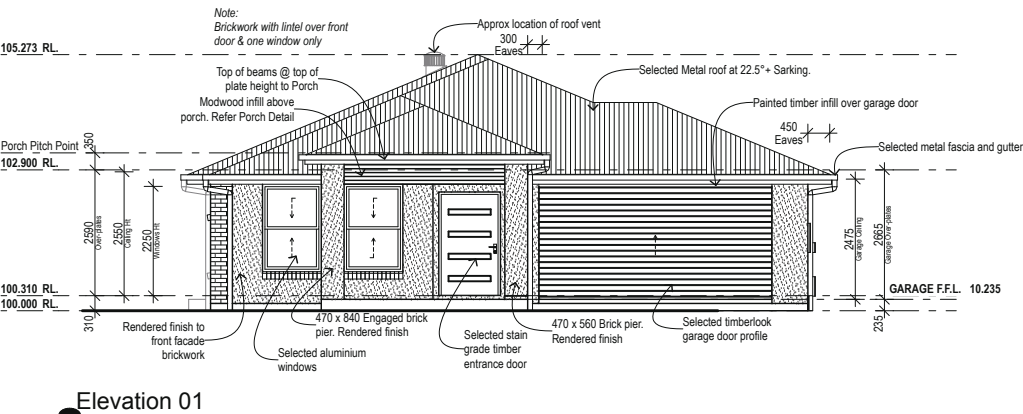

CONSTRUCTION SET / CDC/109688 Dated: 07/09/2018



Address: P.O. BOX 600  
PARADISE POINT, 4216  
www.gdevelopments.com.au  
ACN: 116332220  
ABN: 77116332220  
QBSA: 1086689  
"Building a Shared Vision"

All Content Copyrighted:  
This design and/or print is the property of G Developments Pty and is collected by the Commonwealth Copyright Act 1968. It must not be used or reproduced in whole or in part without written permission. Any attempt to copy, use or reproduce the same, in whole or in part, will result in legal proceedings.  
GENERAL NOTES:  
Drawings are to be read in conjunction with the relevant client-builder contract. Contract is to take precedence over drawings including but not limited to: Details, inclusions, exclusions, additional costs and works by the client-builder. Incomplete drawings or omissions or typographical errors are not to be used in the interpretation of any information in these drawings. Nor can they be used to claim any additional or different services or as a result of such errors, the incorrect or omitted details shall be subject to subsequent correction by the building company and documentation is to be issued.  
DIMENSIONS TO BE READ IN PREFERENCE TO SCALING

Rev	Date	Description "I & O not used"
C	11/09/2018	Construction Set, Incl PCV/1
B	17/07/2018	Complete Pre-Construction Set, Incl. Basic Certificate
A	04/07/2018	Complete Pre-Construction Set

Client Approval: \_\_\_\_\_ Date: \_\_\_\_\_  
"Once this set of plans has been signed off, G Developments will not accept any more changes"

Product:  
**Salerno**  
**Facade Plantation**  
**Garage to Right**

Plot Date: 14/09/2018  
Scale: 1:100  
Sheet: 4

Elevations		
Plot Date: 14/09/2018	Drawn: MAD	Rev: C
Scale: 1:100	Checked: WM	Checked Date: 11/09/2018
Sheet: 4	Job No: MAD Ref: MAD-2018074	N405410

N1 (W28) Wind Category

Bushfire Attack Level  
"LOW"



Refer to BAL Certificate  
Ref. BPD-PA-26512 - Dated: 23/04/2018

Note: 450mm Eave U.N.O.


Note: Fly screens to all windows & sliding glass door

Entry door note:  
Entry door style shown is indicative only.  
Refer to the contract for further details

Provide full ht. Masonry articulation at 5.0m  
max. Crs as per engineers report

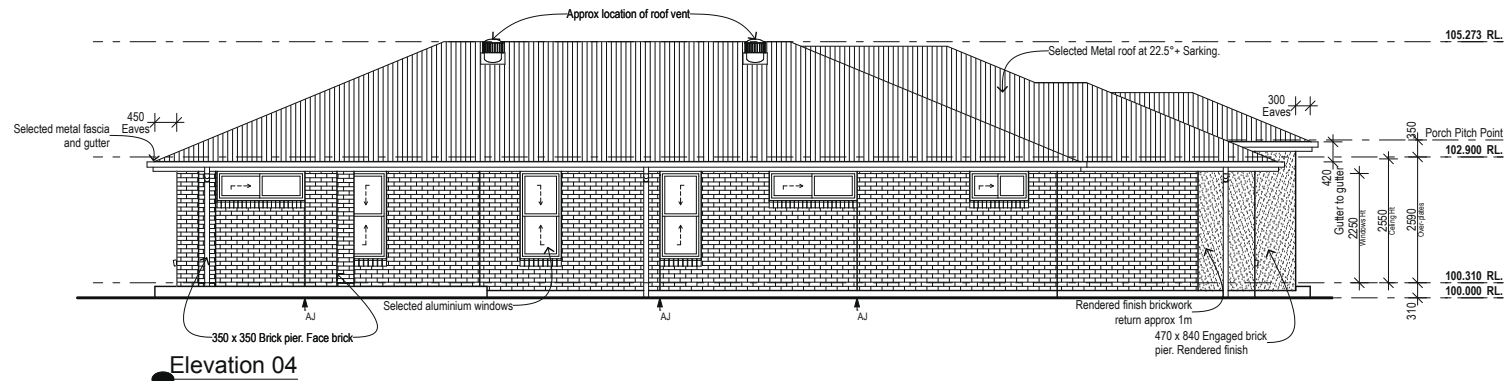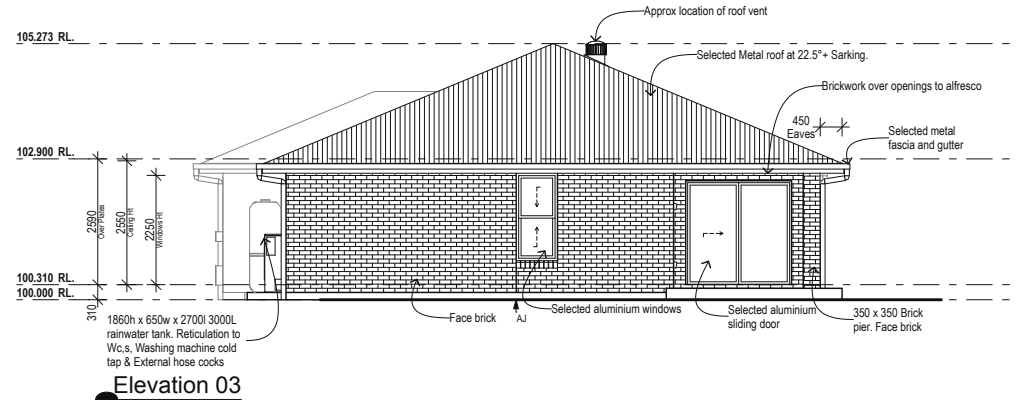

 CONSTRUCTION SET / CDC/109688 Dated: 07/09/2018

 <p>Address: P.O. BOX 600 PARADISE POINT, 4216 www.gdevelopments.com.au</p> <p>ACN: 114332220 ABN: 77114332220 QBSA: 1086689</p> <p>"Building a Shared Vision"</p>	<p>All Content Copyrighted:- This design and/or part is the property of G Developments Pty Ltd and is protected by the Commonwealth Copyright Act 1968. It must not be used or reproduced in whole or in part without written permission. Any attempt to copy, use or reproduce the same, in whole or in part, will result in legal proceedings.</p> <p>GENERAL NOTES: Drawings are to be read in conjunction with the relevant client-builder contract. Contract is to take precedence over drawings including but not limited to: fixtures, inclusions, upgrades, exclusions, additional costs and materials. For the owner/builder, incorrect inclusions or omissions or topographical errors are not to be used in the interpretation of any information in these drawings. Nor can they be used to claim any additional or alternate items or services as a result of such errors. The incorrect or omitted details shall be subject to subsequent correction by the building company and documentation re-issued.</p> <p>DIMENSIONS TO BE READ IN PREFERENCE TO SCALING</p>	<table><tr><th>Rev</th><th>Date</th><th>Description "I &amp; O not used"</th></tr><tr><td>C</td><td>11/09/2018</td><td>Construction Set. Ind PCV/1</td></tr><tr><td>B</td><td>17/07/2018</td><td>Complete Pre-Construction Set. Ind. Basic Certificate</td></tr><tr><td>A</td><td>04/07/2018</td><td>Complete Pre-Construction Set</td></tr></table>	Rev	Date	Description "I & O not used"	C	11/09/2018	Construction Set. Ind PCV/1	B	17/07/2018	Complete Pre-Construction Set. Ind. Basic Certificate	A	04/07/2018	Complete Pre-Construction Set			
		Rev	Date	Description "I & O not used"													
		C	11/09/2018	Construction Set. Ind PCV/1													
		B	17/07/2018	Complete Pre-Construction Set. Ind. Basic Certificate													
		A	04/07/2018	Complete Pre-Construction Set													
Client Approval: _____	Date: _____																
"Once this set of plans has been signed off, G Developments will not accept any more changes"																	
		Product:															
		<b>Salerno</b>															
		<b>Facade Plantation</b>															
		<b>Garage to Right</b>															
<table><tr><th colspan="3">Elevations</th></tr><tr><td>Plot Date: 14/09/2018</td><td>Drawn: MAD</td><td>Rev: <b>C</b></td></tr><tr><td>Scale: 1:100</td><td>Checked: WM</td><td>Checked Date: 11/09/2018</td></tr><tr><td>Sheet: <b>5</b></td><td>Job No: <b>N405410</b></td><td>MAD Ref: MAD-2518074</td></tr></table>						Elevations			Plot Date: 14/09/2018	Drawn: MAD	Rev: <b>C</b>	Scale: 1:100	Checked: WM	Checked Date: 11/09/2018	Sheet: <b>5</b>	Job No: <b>N405410</b>	MAD Ref: MAD-2518074
Elevations																	
Plot Date: 14/09/2018	Drawn: MAD	Rev: <b>C</b>															
Scale: 1:100	Checked: WM	Checked Date: 11/09/2018															
Sheet: <b>5</b>	Job No: <b>N405410</b>	MAD Ref: MAD-2518074															