

NOTES:
IMAGES ARE DIAGRAMATIC ONLY
REFER TO ELEVATIONS FOR DETAILS

©
ALL CONTENT COPYRIGHTED:-
This design and/or print is the property of G. Bull
and is protected by the Commonwealth Copyright
Act 1968. It must not be used or reproduced in
whole or in part without written permission. Any
attempt to copy, use or reproduce the same, in
whole or in part, will result in legal proceedings.

DIMENSIONS TO BE READ IN
PREFERENCE TO SCALING

CLIENT'S SIGNATURE: _____ DATE: _____

NOTES:


PRODUCT:
Scarborough
Traditional Facade
Garage to LH

"2022 Design Range"

CLIENT:
?? Client Full Name

SITE ADDRESS:
Lot ???
?? Street
?? Suburb, QLD 4???

SALES - 3D images		
DRAWN: ??	DATE: DD.MM.YY	Rev: A
SCALE: ??	CHECKED: ??	
SHEET: 1	JOB No: 405???	

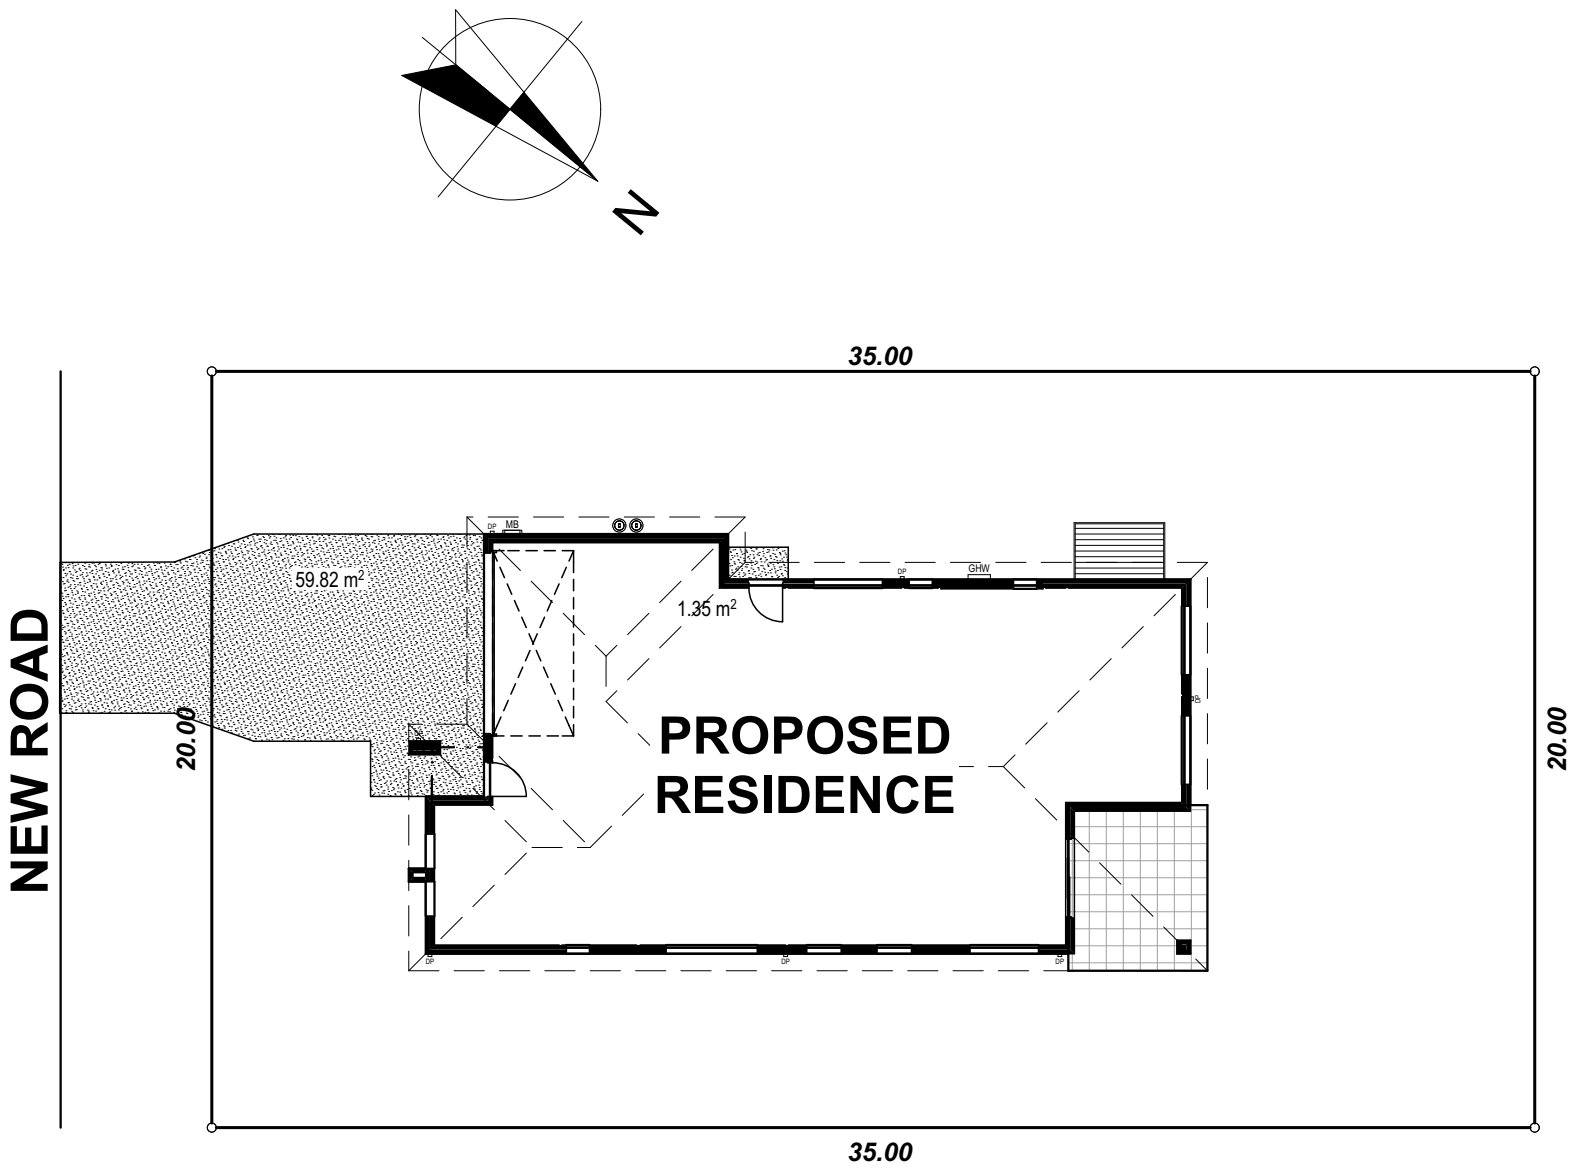

©
ALL CONTENT COPYRIGHTED:-
This design and/or print is the property of G. Bull
and is protected by the Commonwealth Copyright
Act 1968. It must not be used or reproduced in
whole or in part without written permission. Any
attempt to copy, use or reproduce the same, in
whole or in part, will result in legal proceedings.

DIMENSIONS TO BE READ IN
PREFERENCE TO SCALING

CLIENT'S SIGNATURE: _____ DATE: _____

NOTES:


PRODUCT:
Scarborough
Traditional Facade
Garage to LH

"2022 Design Range"

CLIENT:
?? Client Full Name

SITE ADDRESS:
Lot ???
?? Street
?? Suburb, QLD 4???

SALES - Site Plan		
DRAWN: ??	DATE: DD.MM.YY	Rev: A
SCALE: 1:200	CHECKED: ??	
SHEET: 2	JOB No: 405???	

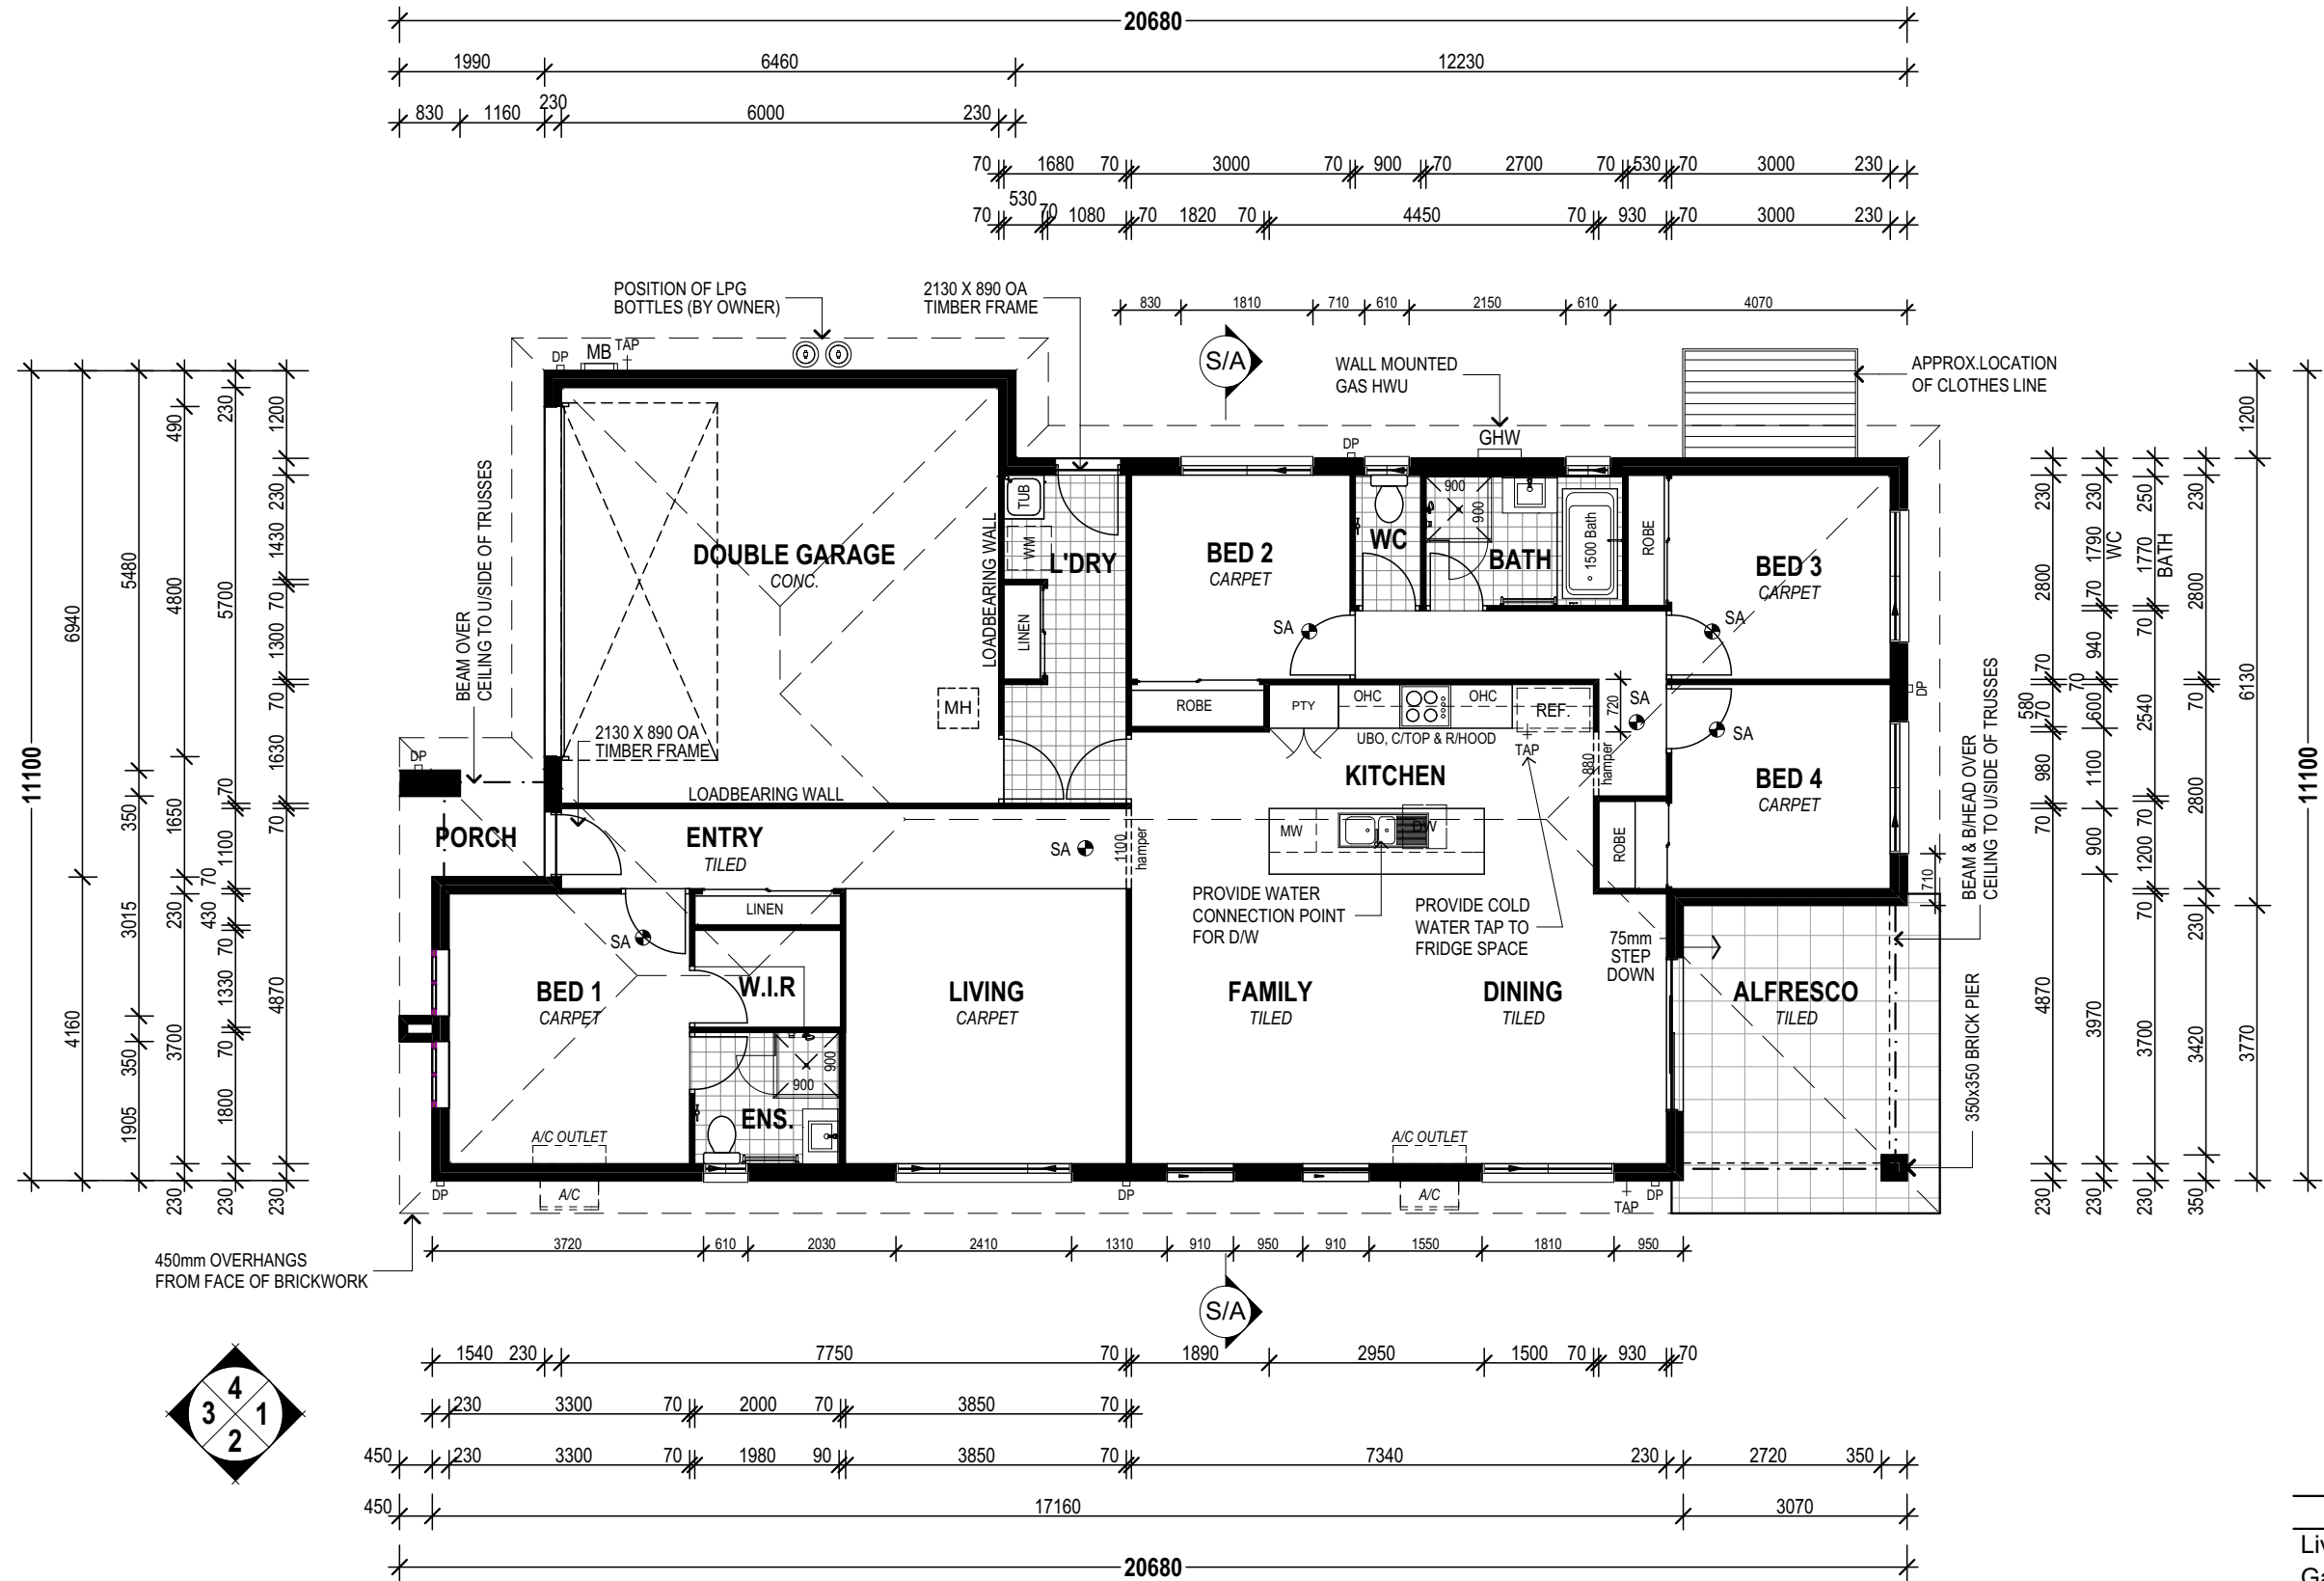

Floor Areas	
Living	150.40
Garage	37.22
Alfresco	15.00
Porch	3.92
206.54 m ²	

ALL CONTENT COPYRIGHTED:-
This design and/or print is the property of G. Bull
and is protected by the Commonwealth Copyright
Act 1968. It must not be used or reproduced in
whole or in part without written permission. Any
attempt to copy, use or reproduce the same, in
whole or in part, will result in legal proceedings.

DIMENSIONS TO BE READ IN
PREFERENCE TO SCALING

CLIENT'S SIGNATURE: _____ DATE: _____

NOTES:


PRODUCT:
**Scarborough
Traditional Facade
Garage to LH**

"2022 Design Range"

CLIENT:
?? Client Full Name

SITE ADDRESS:
**Lot ???
?? Street
?? Suburb, QLD 4???**

SALES - Floor Plan		
DRAWN: ??	DATE: DD.MM.YY	Rev: A
SCALE: 1:100	CHECKED: ??	
SHEET: 3	JOB No: 405???	

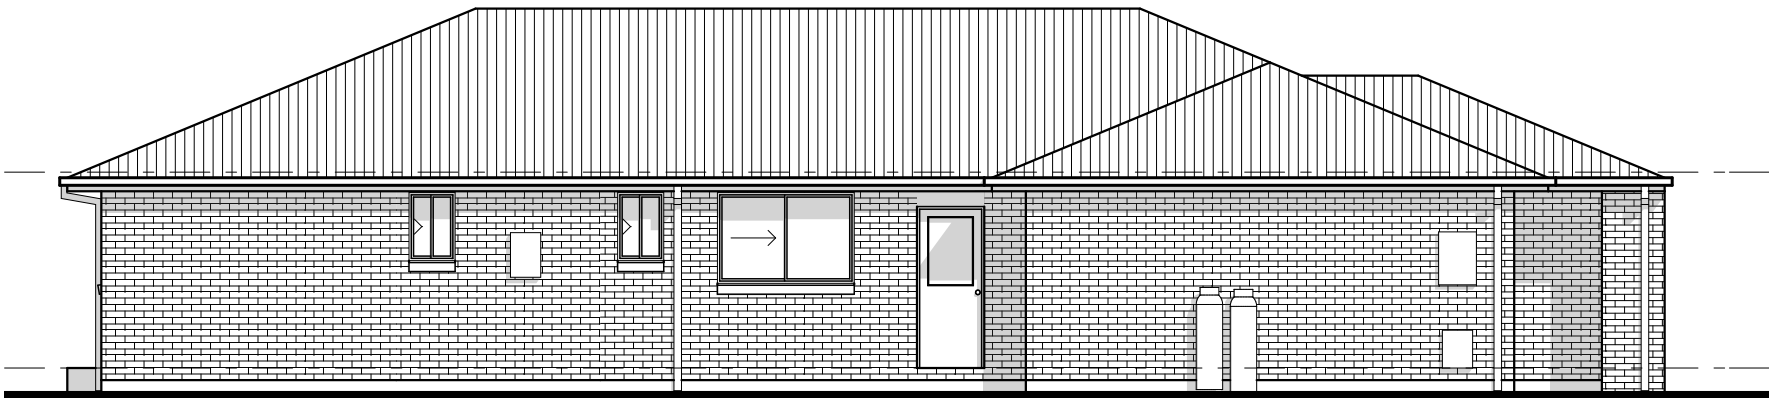

©
ALL CONTENT COPYRIGHTED:-
This design and/or print is the property of G. Bull
and is protected by the Commonwealth Copyright
Act 1968. It must not be used or reproduced in
whole or in part without written permission. Any
attempt to copy, use or reproduce the same, in
whole or in part, will result in legal proceedings.

DIMENSIONS TO BE READ IN
PREFERENCE TO SCALING

CLIENT'S SIGNATURE: _____ DATE: _____

NOTES:


PRODUCT:
Scarborough
Traditional Facade
Garage to LH

"2022 Design Range"

CLIENT:
?? Client Full Name

SITE ADDRESS:
Lot ???
?? Street
?? Suburb, QLD 4???

SALES - Elevations		
DRAWN: ??	DATE: DD.MM.YY	Rev: A
SCALE: 1:100	CHECKED: ??	
SHEET: 4	JOB No: 405???	

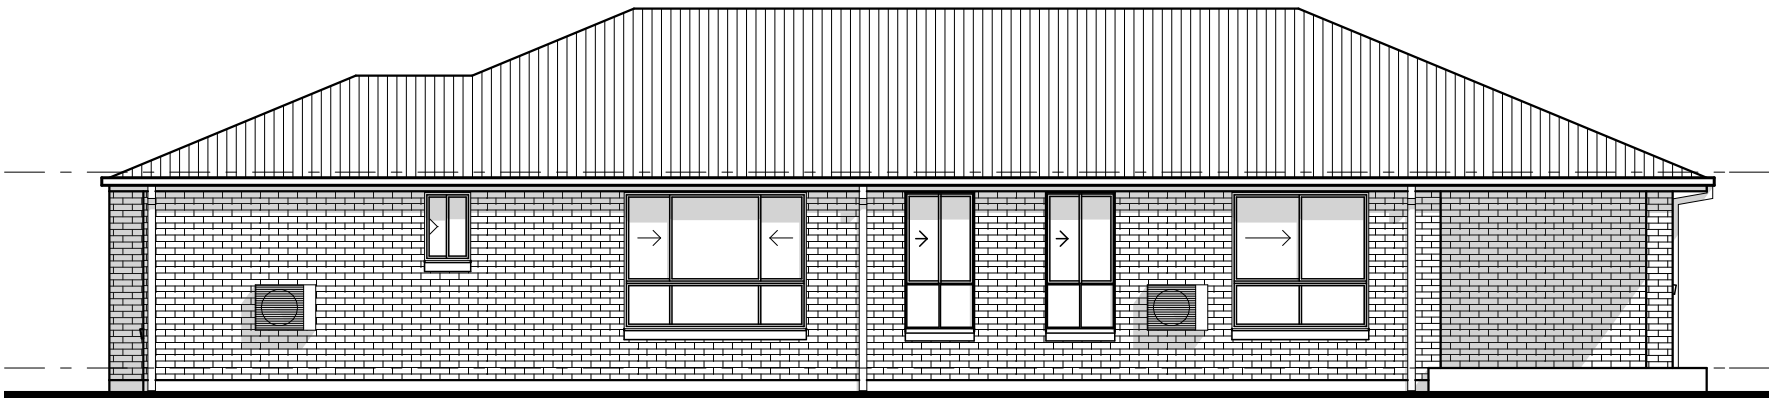

©

ALL CONTENT COPYRIGHTED:-
This design and/or print is the property of G. Bull
and is protected by the Commonwealth Copyright
Act 1968. It must not be used or reproduced in
whole or in part without written permission. Any
attempt to copy, use or reproduce the same, in
whole or in part, will result in legal proceedings.

DIMENSIONS TO BE READ IN
PREFERENCE TO SCALING

CLIENT'S SIGNATURE: _____ DATE: _____

NOTES:

PRODUCT:

**Scarborough
Traditional Facade
Garage to LH**

"2022 Design Range"

CLIENT:

?? Client Full Name

SITE ADDRESS:

**Lot ???
?? Street
?? Suburb, QLD 4???**

SALES - Elevations

DRAWN:

??

DATE:

DD.MM.YY

Rev:

A

SCALE:

1:100

CHECKED:

??












 

 
 

 
 

SHEET:

5

JOB No:

405???

ELECTRICAL LEGEND


 


CODE	TYPE
	SINGLE POWER POINT (GPO)
	DOUBLE POWER POINT (GPO)
	DOWNLIGHT - LED
	LIGHT POINT - BAYONET
	LIGHT POINT - PENDANT
	LIGHT POINT - CIRCULAR FLURO
	LIGHT POINT - SINGLE FLURO
	LIGHT POINT - PARA FLOOD
	PHONE POINT
	DATA POINT
	TV POINT
	CEILING EXHAUST FAN
	HEATER LIGHT FAN - 2
	HEATER LIGHT FAN - 4
	SMOKE DETECTOR
	CEILING FAN
	CEILING FAN & LIGHT
	FOXTEL POINT
	SKYLIGHT - LIGHT TUBE

- LIGHT SWITCHES AT 1350mm ABOVE AFL
 - WALL MOUNTED LIGHTS AT 2000 ABOVE FL
 - POWER OUTLETS AT 300mm ABOVE FL (EXCEPT FOR THE FOLLOWING)
- | | |
|---------------------------|------------------------|
| 1000 - KITCHEN BENCH | 750 - DISHWASHER (DW) |
| 1800 - RANGEHOOD (RH) | 1500 - WASHING MACHINE |
| 750 - MICROWAVE w/bench | 1000 - LAUNDRY BENCH |
| 1500 - REFRIGERATOR (REF) | 1000 - VANITIES |

SMOKE DETECTORS
APPROX. POSITION - INSTALLED AS PER
B.C.A. 3.7.2 & COMPLY WITH A.S.3786

EXHAUST FANS
TO COMPLY WITH A.S.1668.2.
INSTALLED AS PER B.C.A. 3.8.5


COMMUNICATIONS PRE-
WIRED

- * LEAD IN CABINET (NETWORK TERMINATION DEVICE) 
- * WIRING CABINET (POWER SUPPLY UNIT) 
- * GPO NEAR WIRING CABINET 
- * LEAD IN CONDUIT (PREMISES CONNECTION DEVICE) 

ALL ABOVE ITEMS TO FIBRE NETWORK SUPPLIERS
SPECIFICATIONS

FIBRE NETWORK SUPPLIER TO PROVIDE

- * NETWORK TERMINATION DEVICE
- * PSU (BATTERY BACK-UP BY HOME OWNER)

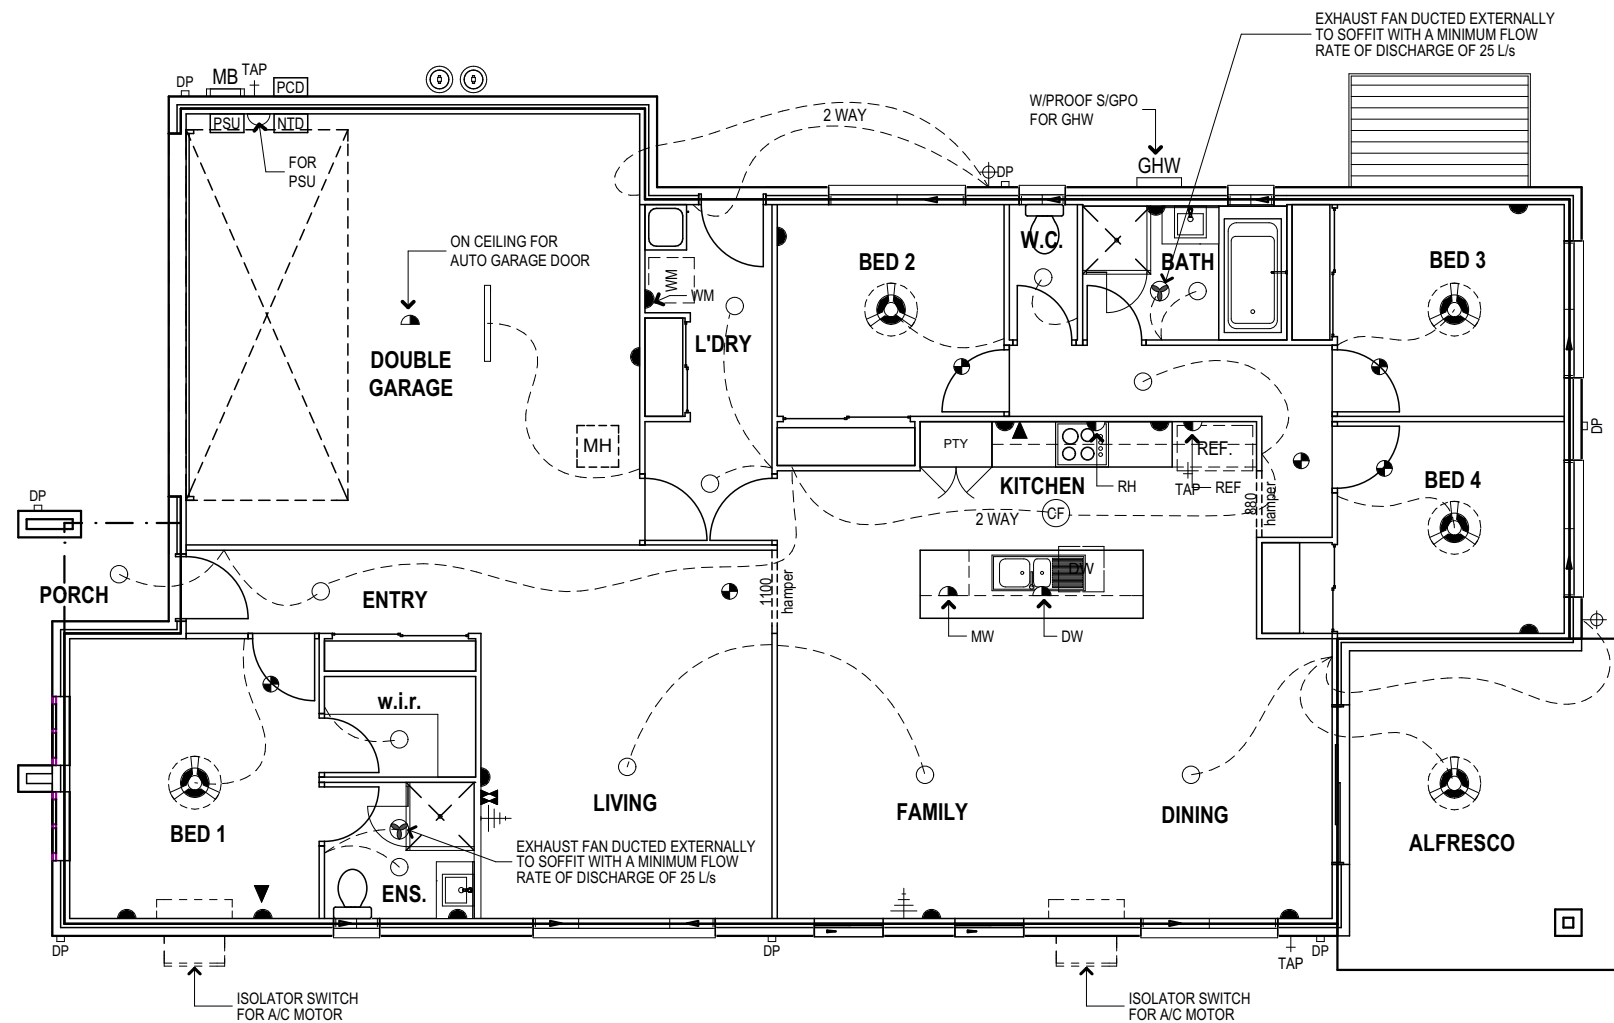

POSITION OF ELECTRICAL POINTS
SUBJECT TO CONSTRUCTION
CONSTRAINTS

©
ALL CONTENT COPYRIGHTED:-
This design and/or print is the property of G. Bull
and is protected by the Commonwealth Copyright
Act 1968. It must not be used or reproduced in
whole or in part without written permission. Any
attempt to copy, use or reproduce the same, in
whole or in part, will result in legal proceedings.

DIMENSIONS TO BE READ IN
PREFERENCE TO SCALING

CLIENT'S SIGNATURE: _____ DATE: _____

NOTES:

PRODUCT:
**Scarborough
Traditional Facade
Garage to LH**

"2022 Design Range"

CLIENT:
?? Client Full Name

SITE ADDRESS:
**Lot ???
?? Street
?? Suburb, QLD 4???**

SALES - Electrical Plan			
DRAWN: ??	DATE: DD.MM.YY	Rev: A	
SCALE: 1:100	CHECKED: ??		
SHEET: 6	JOB No: 405???		